


DWG: F:\2016\3001-3500\016-3375\40-Design\AutoCAD\Final Plans\Sheets\LDVPL_HSC_63375.dwg USER: aasher
 DATE: Feb 01, 2017 3:28pm XREFS: C:\BASE_63375 L_HSSCH_63375 C_TBLK_63375 E_PST_63375

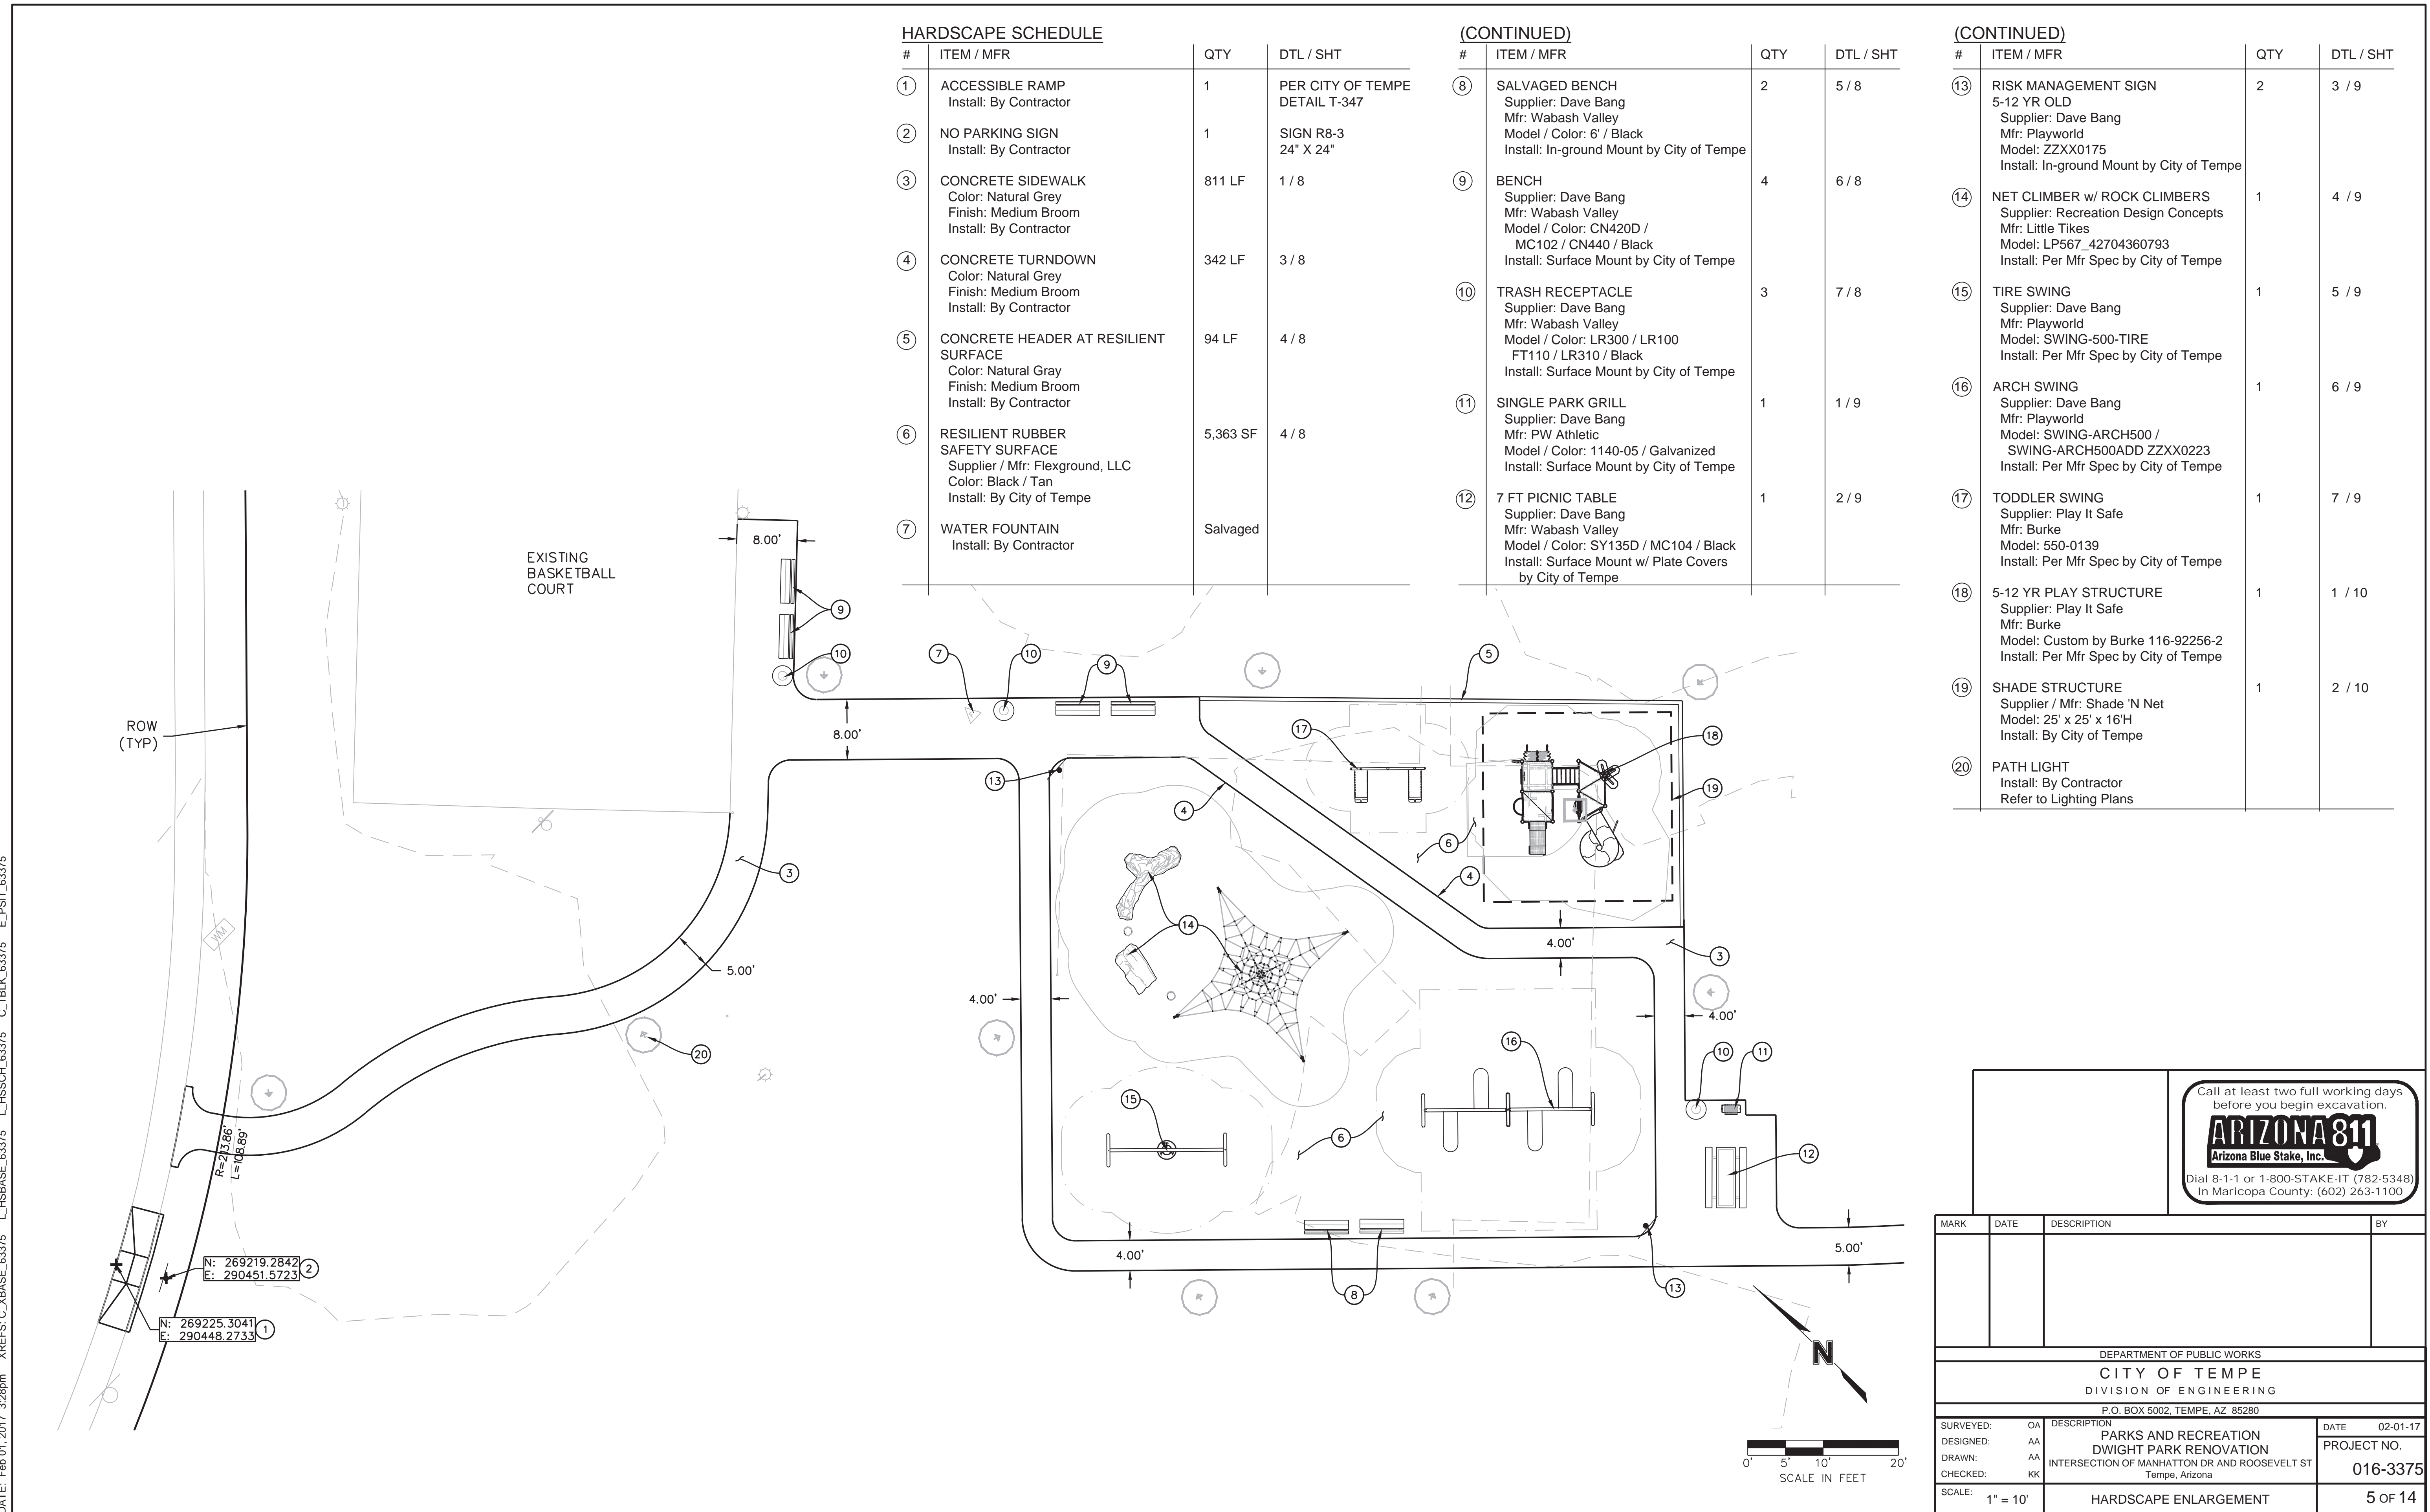

HARDSCAPE SCHEDULE

#	ITEM / MFR	QTY	DTL / SHT
1	ACCESSIBLE RAMP Install: By Contractor	1	PER CITY OF TEMPE DETAIL T-347
2	NO PARKING SIGN Install: By Contractor	1	SIGN R8-3 24" X 24"
3	CONCRETE SIDEWALK Color: Natural Grey Finish: Medium Broom Install: By Contractor	811 LF	1 / 8
4	CONCRETE TURNDOWN Color: Natural Grey Finish: Medium Broom Install: By Contractor	342 LF	3 / 8
5	CONCRETE HEADER AT RESILIENT SURFACE Color: Natural Gray Finish: Medium Broom Install: By Contractor	94 LF	4 / 8
6	RESILIENT RUBBER SAFETY SURFACE Supplier / Mfr: Flexground, LLC Color: Black / Tan Install: By City of Tempe	5,363 SF	4 / 8
7	WATER FOUNTAIN Install: By Contractor	Salvaged	

(CONTINUED)

#	ITEM / MFR	QTY	DTL / SHT
8	SALVAGED BENCH Supplier: Dave Bang Mfr: Wabash Valley Model / Color: 6' / Black Install: In-ground Mount by City of Tempe	2	5 / 8
9	BENCH Supplier: Dave Bang Mfr: Wabash Valley Model / Color: CN420D / MC102 / CN440 / Black Install: Surface Mount by City of Tempe	4	6 / 8
10	TRASH RECEPTACLE Supplier: Dave Bang Mfr: Wabash Valley Model / Color: LR300 / LR100 FT110 / LR310 / Black Install: Surface Mount by City of Tempe	3	7 / 8
11	SINGLE PARK GRILL Supplier: Dave Bang Mfr: PW Athletic Model / Color: 1140-05 / Galvanized Install: Surface Mount by City of Tempe	1	1 / 9
12	7 FT PICNIC TABLE Supplier: Dave Bang Mfr: Wabash Valley Model / Color: SY135D / MC104 / Black Install: Surface Mount w/ Plate Covers by City of Tempe	1	2 / 9

(CONTINUED)

#	ITEM / MFR	QTY	DTL / SHT
13	RISK MANAGEMENT SIGN 5-12 YR OLD Supplier: Dave Bang Mfr: Playworld Model: ZZZX0175 Install: In-ground Mount by City of Tempe	2	3 / 9
14	NET CLIMBER w/ ROCK CLIMBERS Supplier: Recreation Design Concepts Mfr: Little Tikes Model: LP567_42704360793 Install: Per Mfr Spec by City of Tempe	1	4 / 9
15	TIRE SWING Supplier: Dave Bang Mfr: Playworld Model: SWING-500-TIRE Install: Per Mfr Spec by City of Tempe	1	5 / 9
16	ARCH SWING Supplier: Dave Bang Mfr: Playworld Model: SWING-ARCH500 / SWING-ARCH500ADD ZZZX0223 Install: Per Mfr Spec by City of Tempe	1	6 / 9
17	TODDLER SWING Supplier: Play It Safe Mfr: Burke Model: 550-0139 Install: Per Mfr Spec by City of Tempe	1	7 / 9
18	5-12 YR PLAY STRUCTURE Supplier: Play It Safe Mfr: Burke Model: Custom by Burke 116-92256-2 Install: Per Mfr Spec by City of Tempe	1	1 / 10
19	SHADE STRUCTURE Supplier / Mfr: Shade 'N Net Model: 25' x 25' x 16'H Install: By City of Tempe	1	2 / 10
20	PATH LIGHT Install: By Contractor Refer to Lighting Plans		

Call at least two full working days before you begin excavation.

ARIZONA 811
 Arizona Blue Stake, Inc.

Dial 8-1-1 or 1-800-STAKE-IT (782-5348)
 In Maricopa County: (602) 263-1100

MARK	DATE	DESCRIPTION	BY

DEPARTMENT OF PUBLIC WORKS
CITY OF TEMPE
 DIVISION OF ENGINEERING
 P.O. BOX 5002, TEMPE, AZ 85280

SURVEYED: OA	DESCRIPTION: PARKS AND RECREATION	DATE: 02-01-17
DESIGNED: AA	DWIGHT PARK RENOVATION	PROJECT NO.
DRAWN: AA	INTERSECTION OF MANHATTAN DR AND ROOSEVELT ST	016-3375
CHECKED: KK	Tempe, Arizona	

SCALE: 1" = 10' HARDSCAPE ENLARGEMENT 5 OF 14